



LIGHTING SCHEDULE	
MARK	DESCRIPTION
L1	FLUORESCENT FIXTURE - TWO F32T6 LAMPS
L2	EXTERIOR LIGHT FIXTURE
L3	EXTERIOR FLOOD LIGHT W/MOTION DETECTOR
L4	EMERGENCY LIGHT W/BATTERY BACKUP

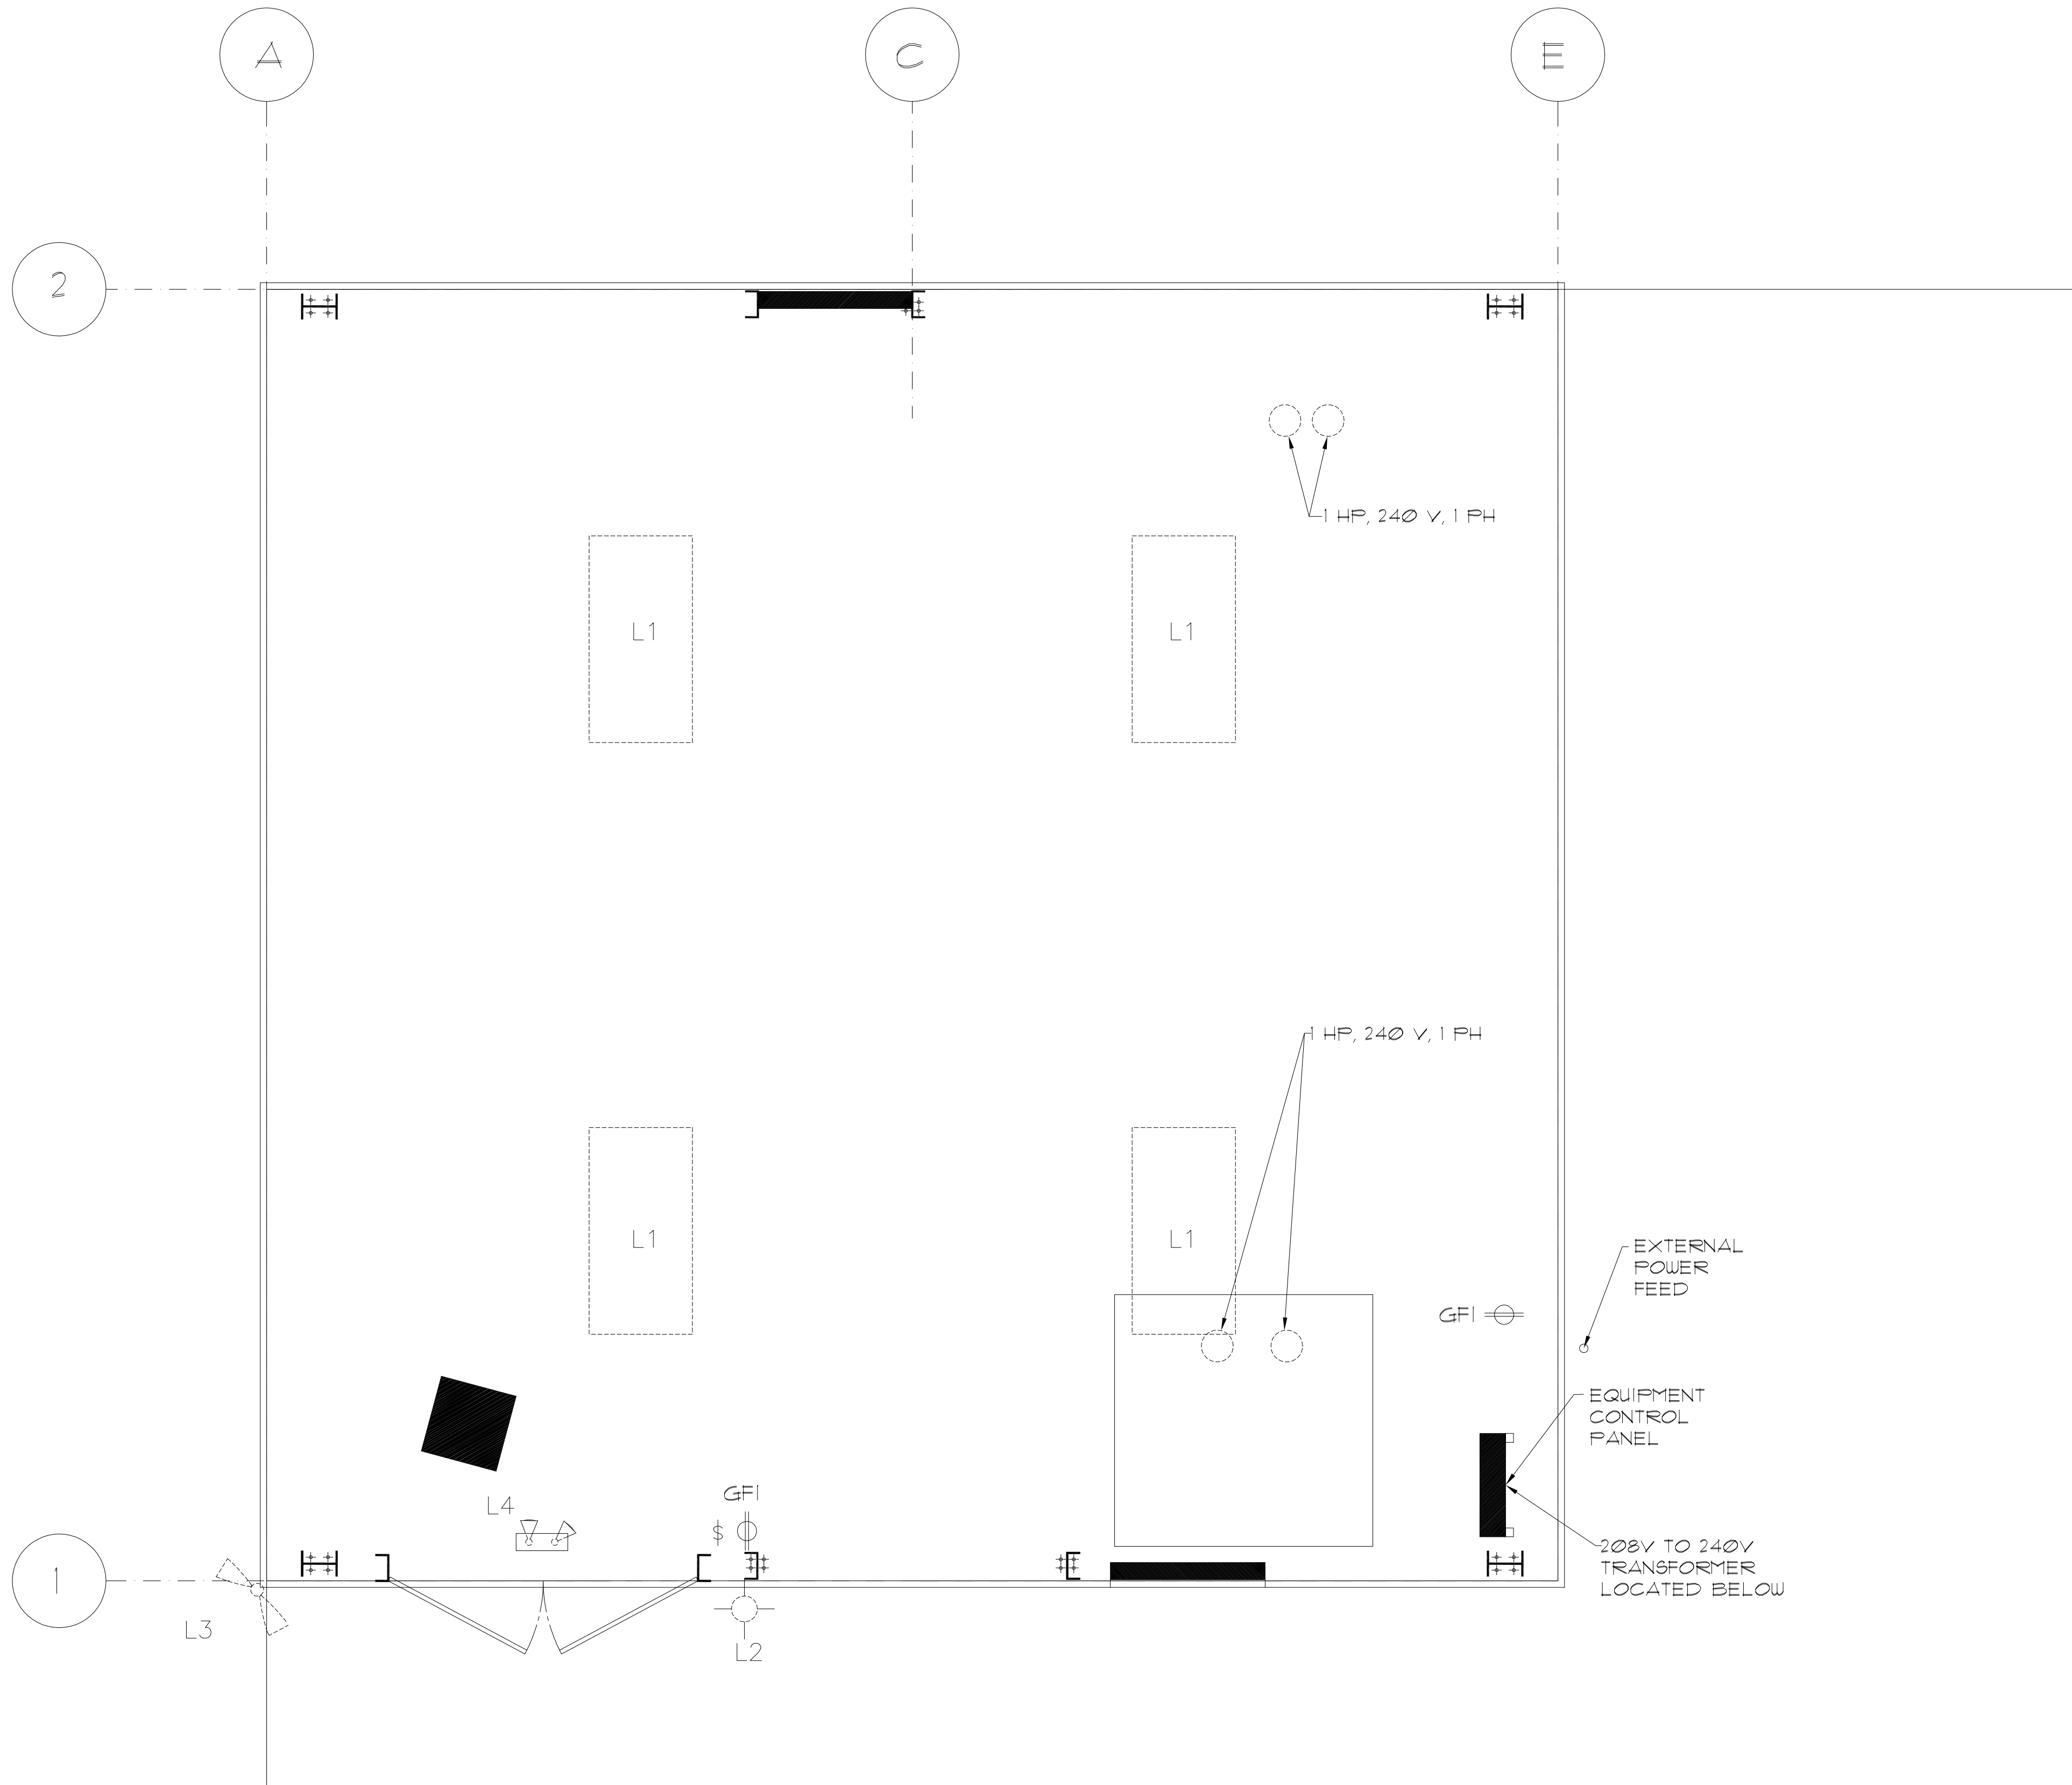

ELECTRICAL PLAN
SCALE= 1/2"=1'-0"

LAST REVISION: 01/15/12
LAST PLOTTED: 01/15/12
DRAWING SCALE: 1/2"=1'
PLOT SCALE: 1=1

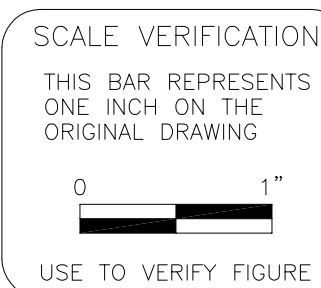

REVISION	DATE	DESCRIPTION	BY	APPROVED
1	12/29/11	AS BUILT REVISIONS	A.A.	

ENGINEER OF RECORD:

AL ANDREANSKY, P.E.
OHIO REG. #75847

DATE SIGNED

CAD FILE: 110222401M SCALE: 1/2"=1'-0"

DRAWN BY: A.A. DATE: 03-19-11

CHECKED BY: DATE:


APPROVED BY: DATE:

AL ANDREANSKY, P.E.
P.O. BOX 456
PALM HARBOR, FLORIDA 34682-0456
PHONE: 17271 460-8612, FAX: 17271 789-9565

BUILDING ELECTRICAL PLAN
2149 WESTERN AVENUE
CINCINNATI, OHIO 45214

[CSX]

CSX INTERMODAL TERMINALS, INC.
TERMINAL DEVELOPMENT GROUP
JACKSONVILLE, FLORIDA

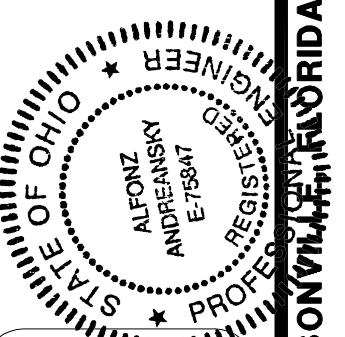

AS-BUILT DRAWINGS

I hereby certify that these "As-Built Drawings" reflect the construction process. They are based upon information furnished to me by the contractor and show the completed construction to the best of my knowledge and belief.

ENGINEER: ALFONSO ANDREANSKY

DATE: 1/15/12

PROJECT No. 11022401.001

SHEET E1 of 1

CINCINNATI TERMINAL, CSX INTERMODAL, JACKSONVILLE, FLORIDA